





COMMERCIAL DESIGN & DEVELOPMENT, INC.  
Specializing in Planning & Development of  
Financial Facilities  
3616 Graham Avenue  
Winber, Pa. 15963 (814) 467-5681

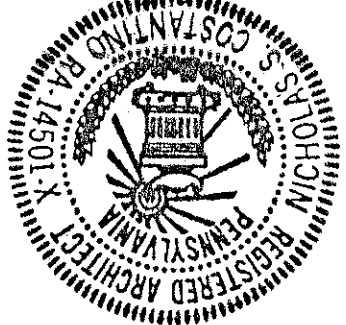

NEW BRANCH OFFICE & TRUST OFFICE FOR  
**MOXHAM NATIONAL BANK**  
550 CENTRAL AVE., JOHNSTOWN, PA. 16802

FLOOR PLAN - HVAC

Printed  
Date 7-7-92  
Scale AS NOTED  
Drawn L.C.D.  
Job  
Sheet H-2

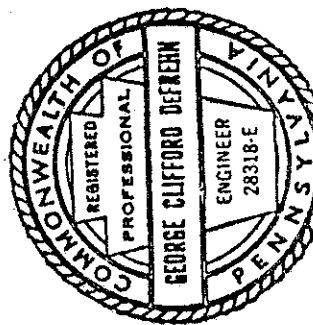

NOTE:  
DO NOT SCALE DRAWING  
Dimensions shown on drawings are for information only. Each contract is to be coordinated with the architect and the engineer. The engineer is not responsible for the accuracy of the dimensions shown on drawings.

- SPECIFIC NOTES**
- 36" X 18" SUPPLY DUCT UP - TRANSITION AS REQUIRED AND CONNECT TO SUPPLY AIR OUTLET ON RTU-1.
  - 36" X 18" SUPPLY DUCT UP - TRANSITION AS REQUIRED AND CONNECT TO SUPPLY AIR OUTLET ON RTU-2.
  - 36" X 18" SUPPLY DUCT UP - TRANSITION AS REQUIRED AND CONNECT TO SUPPLY AIR OUTLET ON RTU-3.
  - 42" X 14" RETURN DUCT UP - TRANSITION AS REQUIRED AND CONNECT TO RETURN AIR INLET ON RTU-1.
  - 42" X 14" RETURN DUCT UP - TRANSITION AS REQUIRED AND CONNECT TO RETURN AIR INLET ON RTU-2.
  - 42" X 14" RETURN DUCT UP - TRANSITION AS REQUIRED AND CONNECT TO RETURN AIR INLET ON RTU-3.


**ELECTRIC INBOARD SCHEDULE**

EBB-1  
1-1/2" X 4'-0" V  
RTU-1  
RTU-2  
RTU-3  
NOTE: CONTROLLED BY UNIT MOUNTED THERMOSTAT

EBB-2  
1-1/2" X 4'-0" V  
RTU-1  
RTU-2  
RTU-3  
NOTE: CONTROLLED BY UNIT MOUNTED THERMOSTAT

**LEGEND**

SYM. BETWEEN  
E.C. ELECTRICAL SUB-CONTRACTOR  
E.H. EXHAUST  
G.C. GENERAL CONTRACTOR  
H.C. HEATING SUB-CONTRACTOR  
M.D. MECHANICAL DUCT  
P.C. PLUMBING SUB-CONTRACTOR  
T.S. THERMOSTAT  
TYP. TRANSITION  
W/ WITH  
FLEXIBLE DUCT  
UNDER DUCT 3/4" BY G.C.  
LOWER DOOR 1 SQ. FT. FREE AREA BY G.C.

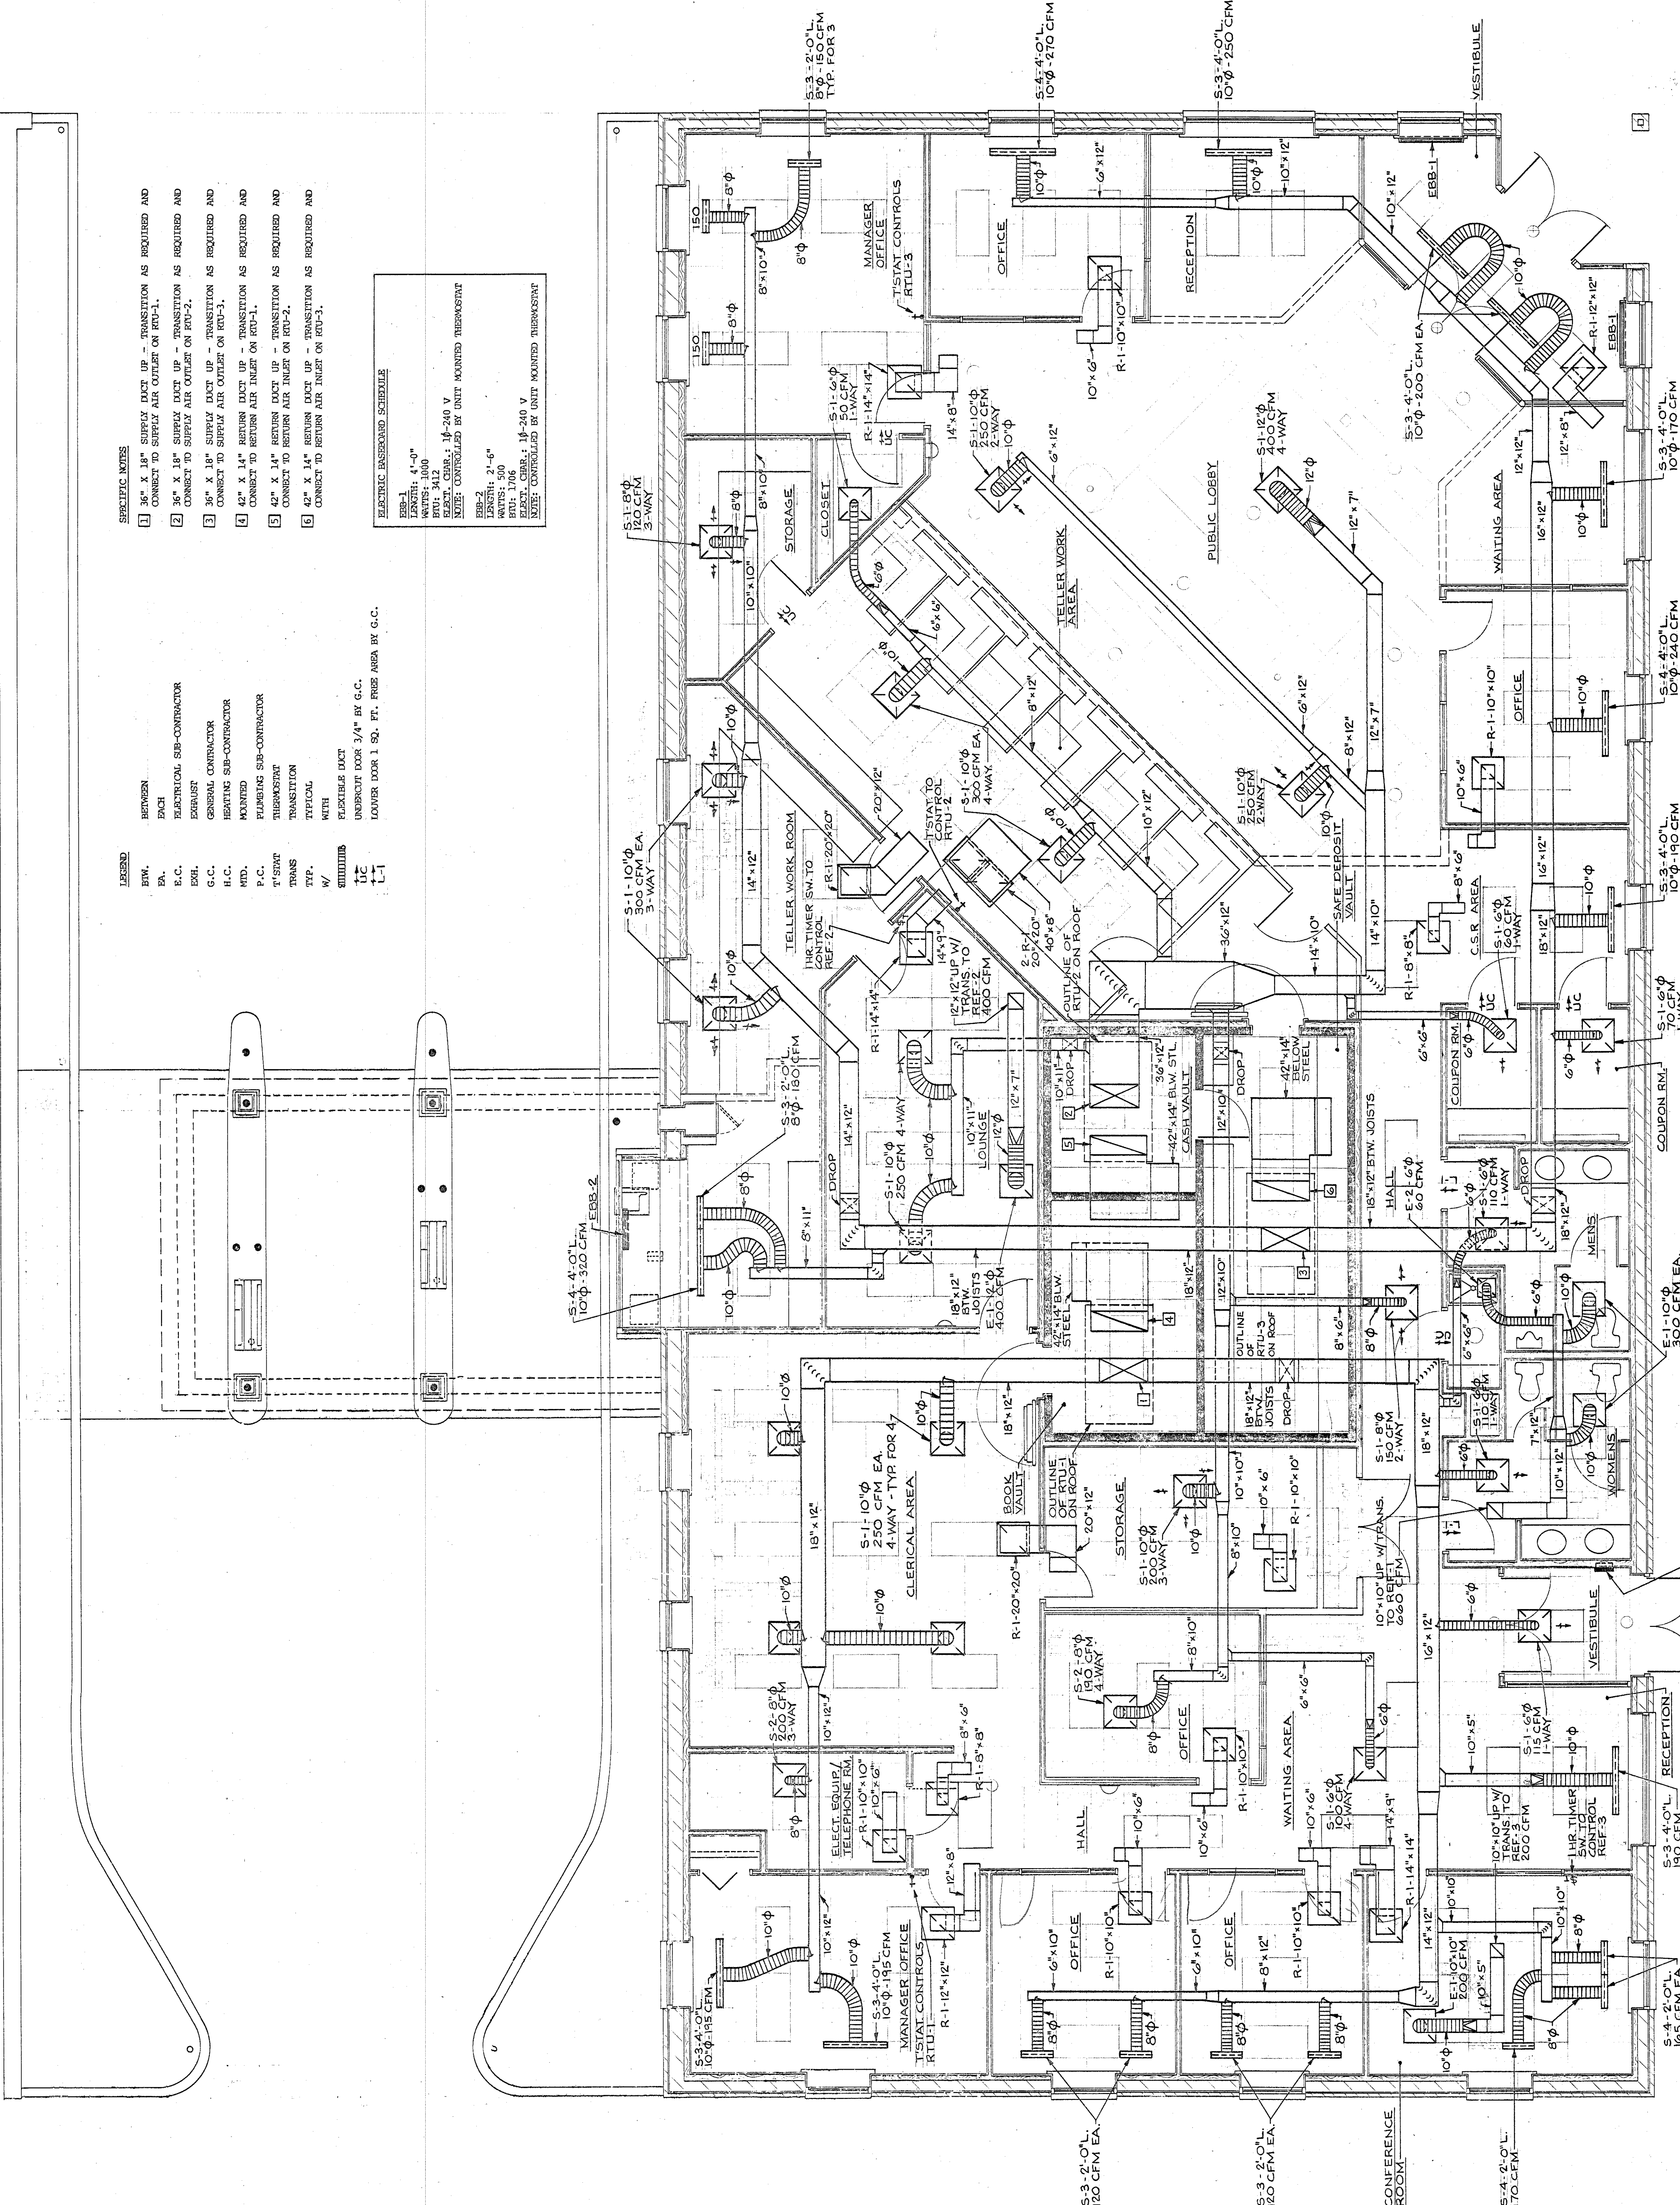

FLOOR PLAN - H.V.A.C.  
SCALE 1/4" = 1'-0"